


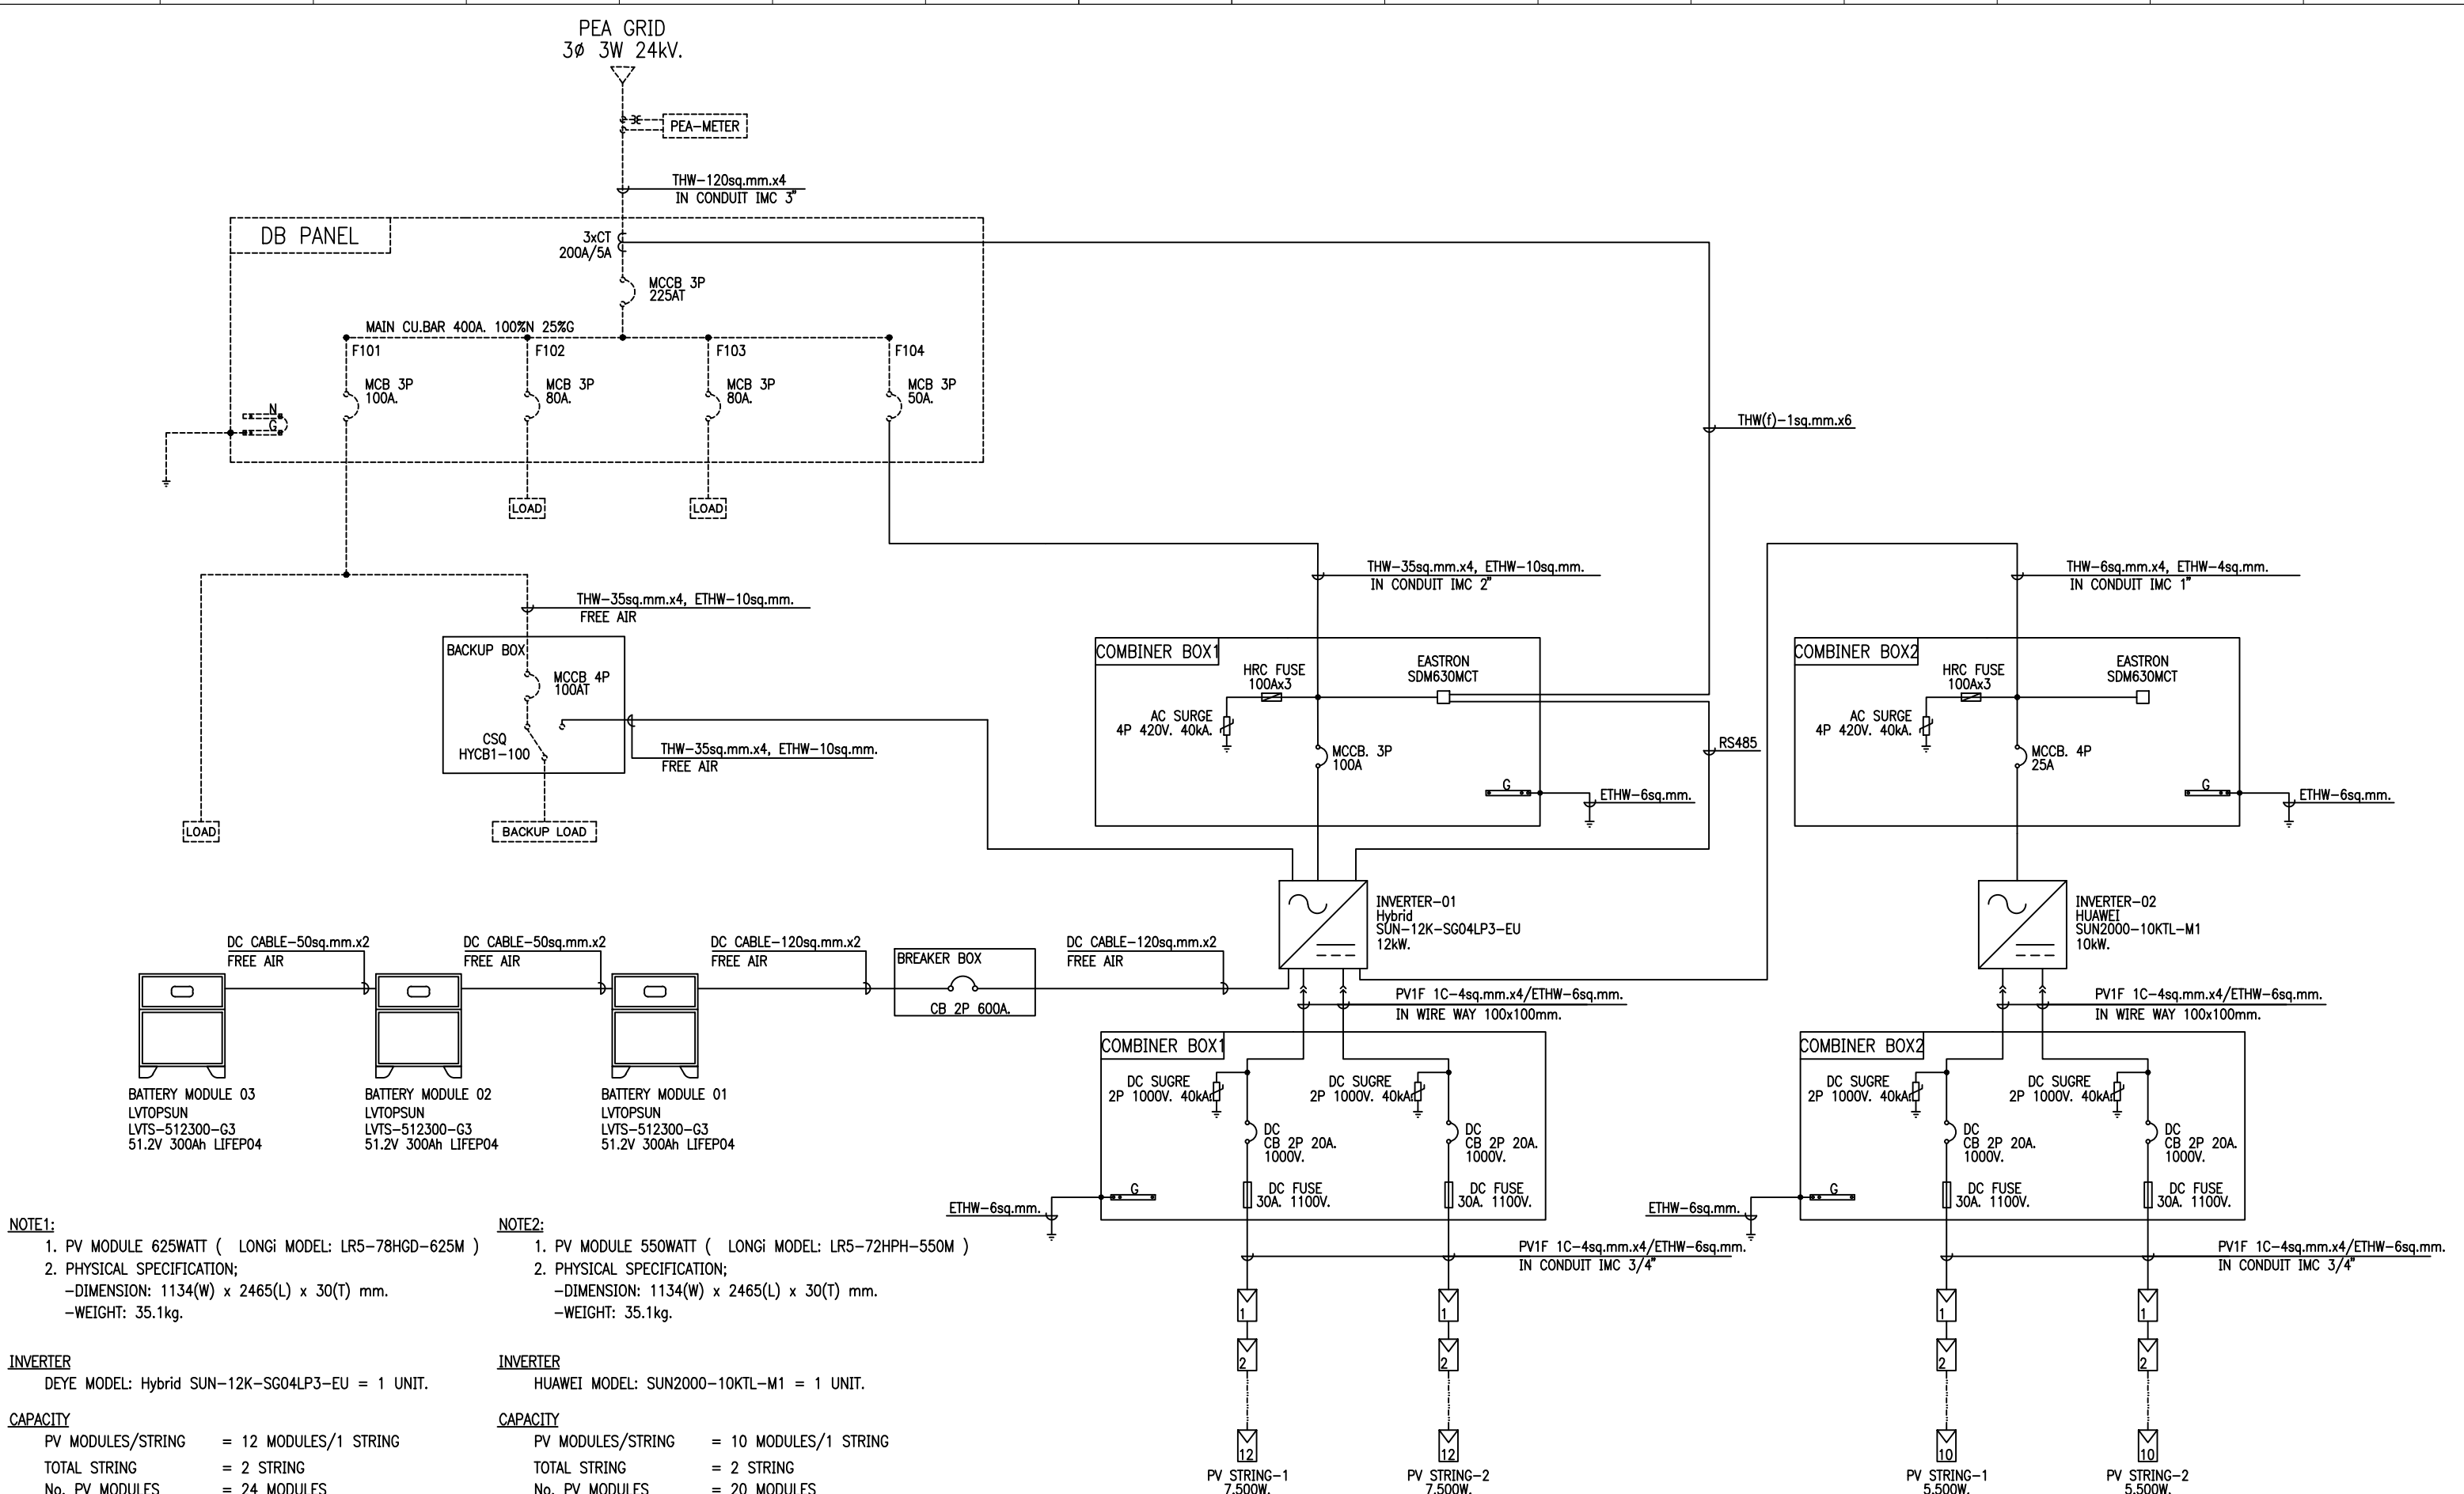

NOTE1:

1. PV MODULE 625WATT (LONGi MODEL: LR5-78HGD-625M)
2. PHYSICAL SPECIFICATION;
-DIMENSION: 1134(W) x 2465(L) x 30(T) mm.
-WEIGHT: 35.1kg.

INVERTER
DEYE MODEL: Hybrid SUN-12K-SG04LP3-EU = 1 UNIT.

CAPACITY

PV MODULES/STRING	= 12 MODULES/1 STRING
TOTAL STRING	= 2 STRING
No. PV MODULES	= 24 MODULES
TOTAL CAPACITY	= 15.00 kWp

NOTE2:

1. PV MODULE 550WATT (LONGi MODEL: LR5-72HPH-550M)
2. PHYSICAL SPECIFICATION;
-DIMENSION: 1134(W) x 2465(L) x 30(T) mm.
-WEIGHT: 35.1kg.

INVERTER
HUAWEI MODEL: SUN2000-10KTL-M1 = 1 UNIT.

CAPACITY

PV MODULES/STRING	= 10 MODULES/1 STRING
TOTAL STRING	= 2 STRING
No. PV MODULES	= 20 MODULES
TOTAL CAPACITY	= 11.00 kWp

Solar Cell System Single Line Diagram
SCALE NONE

OFFTAKER :				OWNER :				CONTRACTOR :				PROJECT NAME				DRAWING TITLE:			
				ทรัพย์สินวิสต์เพลส - หอพักหน้า ม.ตรัง								ทรัพย์สินวิสต์เพลส - หอพักหน้า ม.ตรัง 26kW 3Ph 4String				Solar Cell System Single Line Diagram			
																DRAWING NO.: 001			
																DATE :		SCALE :	
																		SHEET NO. :	
																		TOTAL NO. :	
																		1	
																		1	