


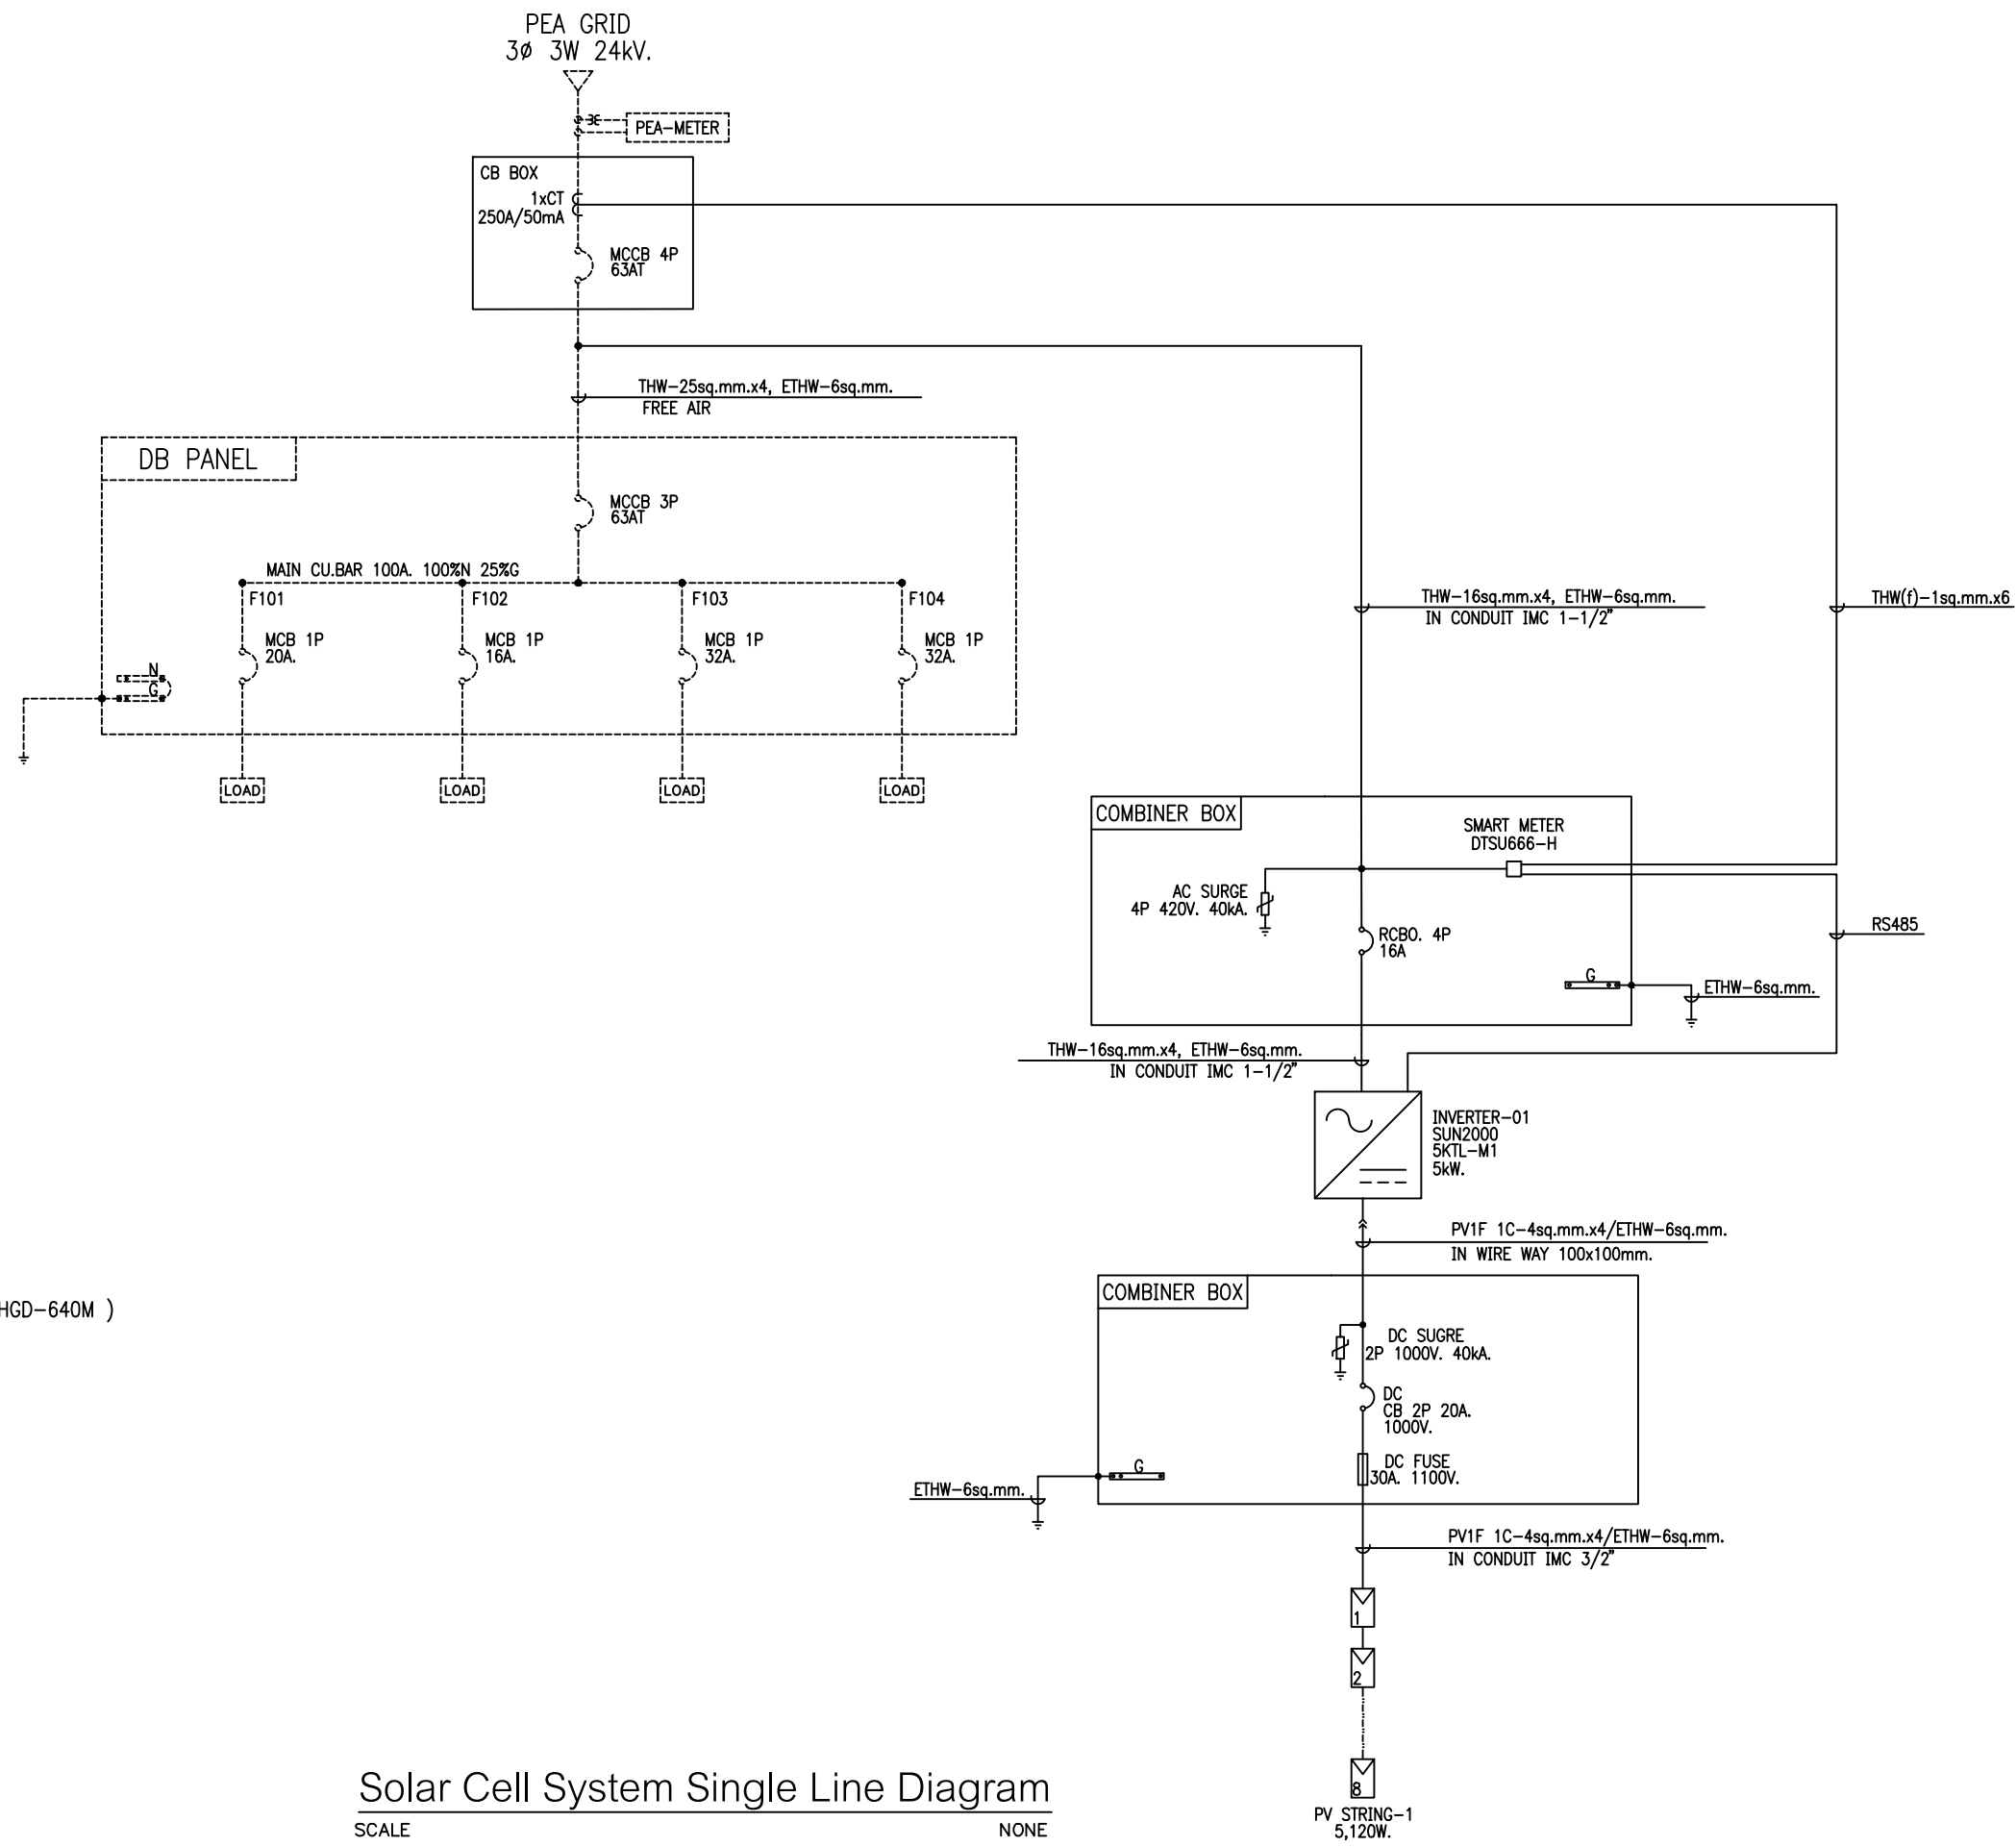

NOTE:
1. PV MODULE 640WATT (LONGi MODEL: LR5-78HGD-640M)
2. PHYSICAL SPECIFICATION;
-DIMENSION: 1134(W) x 2465(L) x 30(T) mm.
-WEIGHT: 35.1kg.

INVERTER
HUAWEI MODEL: SUN2000 5KTL-M1 = 1 UNIT.

CAPACITY
PV MODULES/STRING = 8 MODULES/1 STRING
TOTAL STRING = 1 STRING
No. PV MODULES = 8 MODULES
TOTAL CAPACITY = 5.12 kWp

Solar Cell System Single Line Diagram
SCALE NONE

AS-BUILT DRAWING

OFFTAKER :			OWNER :			CONTRACTOR :			PROJECT NAME			STRUCTURAL ENGINEER:		DRAWN BY:				DRAWING TITLE:	
												ARCHITECT:		CHECKED BY:				Solar Cell System Single Line Diagram	
			รพสต สันกำแพง บ้านตลาด						รพสต สันกำแพง บ้านตลาด 5.12kW 3Ph 1String			ELECTRICAL ENGINEER: <u>เชิดศักดิ์ ชื่นขันธ์</u>		APPROVED BY: <u>เชิดศักดิ์ ชื่นขันธ์</u>		0		AS-BUILT DRAWING	
																NO.		DESCRIPTION	
												MECHANICAL ENGINEER:						DATE	
																ISSUES AND REVISIONS		DATE :	
																		SCALE : NTS	
																		SHEET NO. : 1	
																		TOTAL NO. : 1	

STRUCTURAL ENGINEER:	DRAWN BY:			
ARCHITECT:	CHECKED BY:			
ELECTRICAL ENGINEER: เป็รดิษฐ์ ชินขัท	APPROVED BY: เป็รดิษฐ์ ชินขัท	0	AS-BUILT DRAWING	
MECHANICAL ENGINEER:		NO.	DESCRIPTION	DATE
ISSUES AND REVISIONS				