

NOTE:

1. PV MODULE 630WATT (LONGi MODEL: LR5-78HGD-630M)
2. PHYSICAL SPECIFICATION;
-DIMENSION: 1134(W) x 2465(L) x 30(T) mm.
-WEIGHT: 35.1kg.

INVERTER


SOLIS MODEL: S6-EH1P6K-L-PLUS = 1 UNIT.

BATTERY

LVTOPSUN MODEL: LVTS-512300 = 2 UNIT.

CAPACITY

PV MODULES/STRING = 7 MODULES/1 STRING
TOTAL STRING = 2 STRING
No. PV MODULES = 14 MODULES
TOTAL CAPACITY = 8.82 kWp

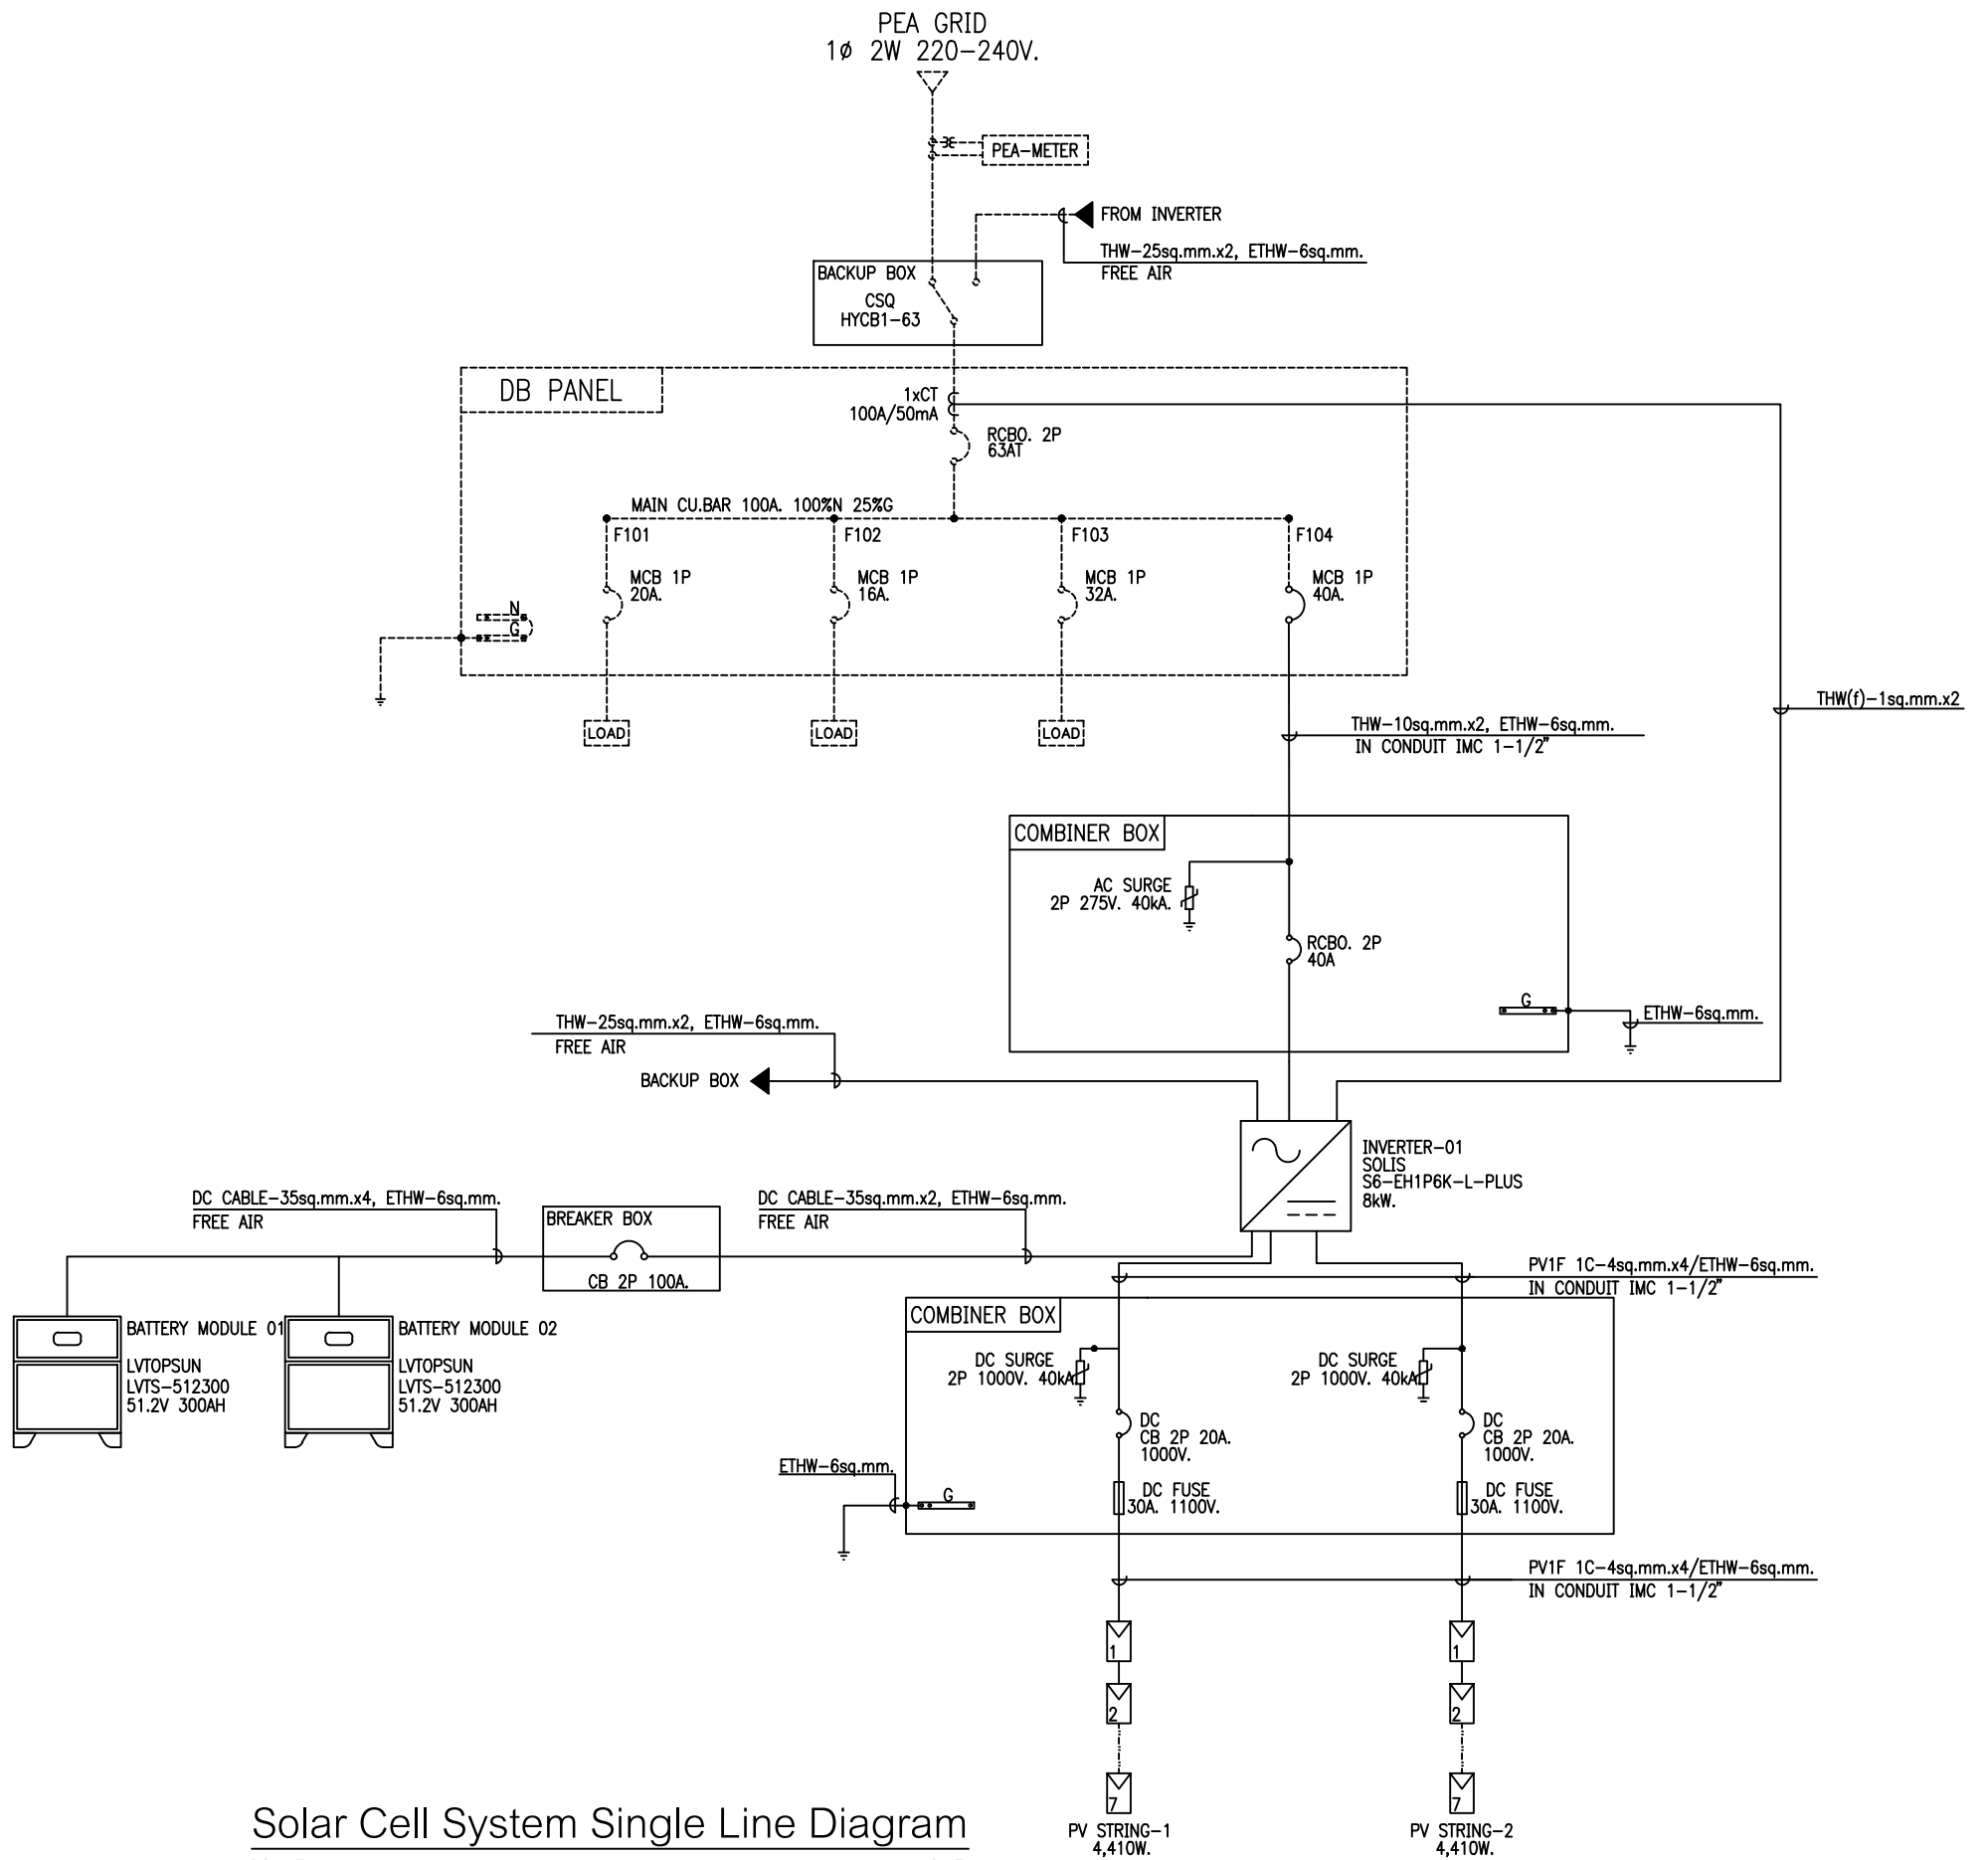

Solar Cell System Single Line Diagram

SCALE NONE

AS-BUILT DRAWING

OFFTAKER :

OWNER :

คุณเสาวลักษณ์ ช่วยกิตติ

CONTRACTOR :



SOLAR ESS CO., LTD.

PROJECT NAME

คุณเสาวลักษณ์ ช่วยกิตติ 8.82kW 1Ph 2String

STRUCTURAL ENGINEER:

DRAWN BY:

ARCHITECT:

CHECKED BY:

ELECTRICAL ENGINEER: ปิยะสิทธิ์ ชื่นพินิต

APPROVED BY: ปิยะสิทธิ์ ชื่นพินิต

MECHANICAL ENGINEER:

NO.

DESCRIPTION

DATE

ISSUES AND REVISIONS

DRAWING TITLE:

Solar Cell System Single Line Diagram

DRAWING NO.:

001

DATE :

SCALE :

NTS

SHEET NO. :

1

TOTAL NO. :

1