
 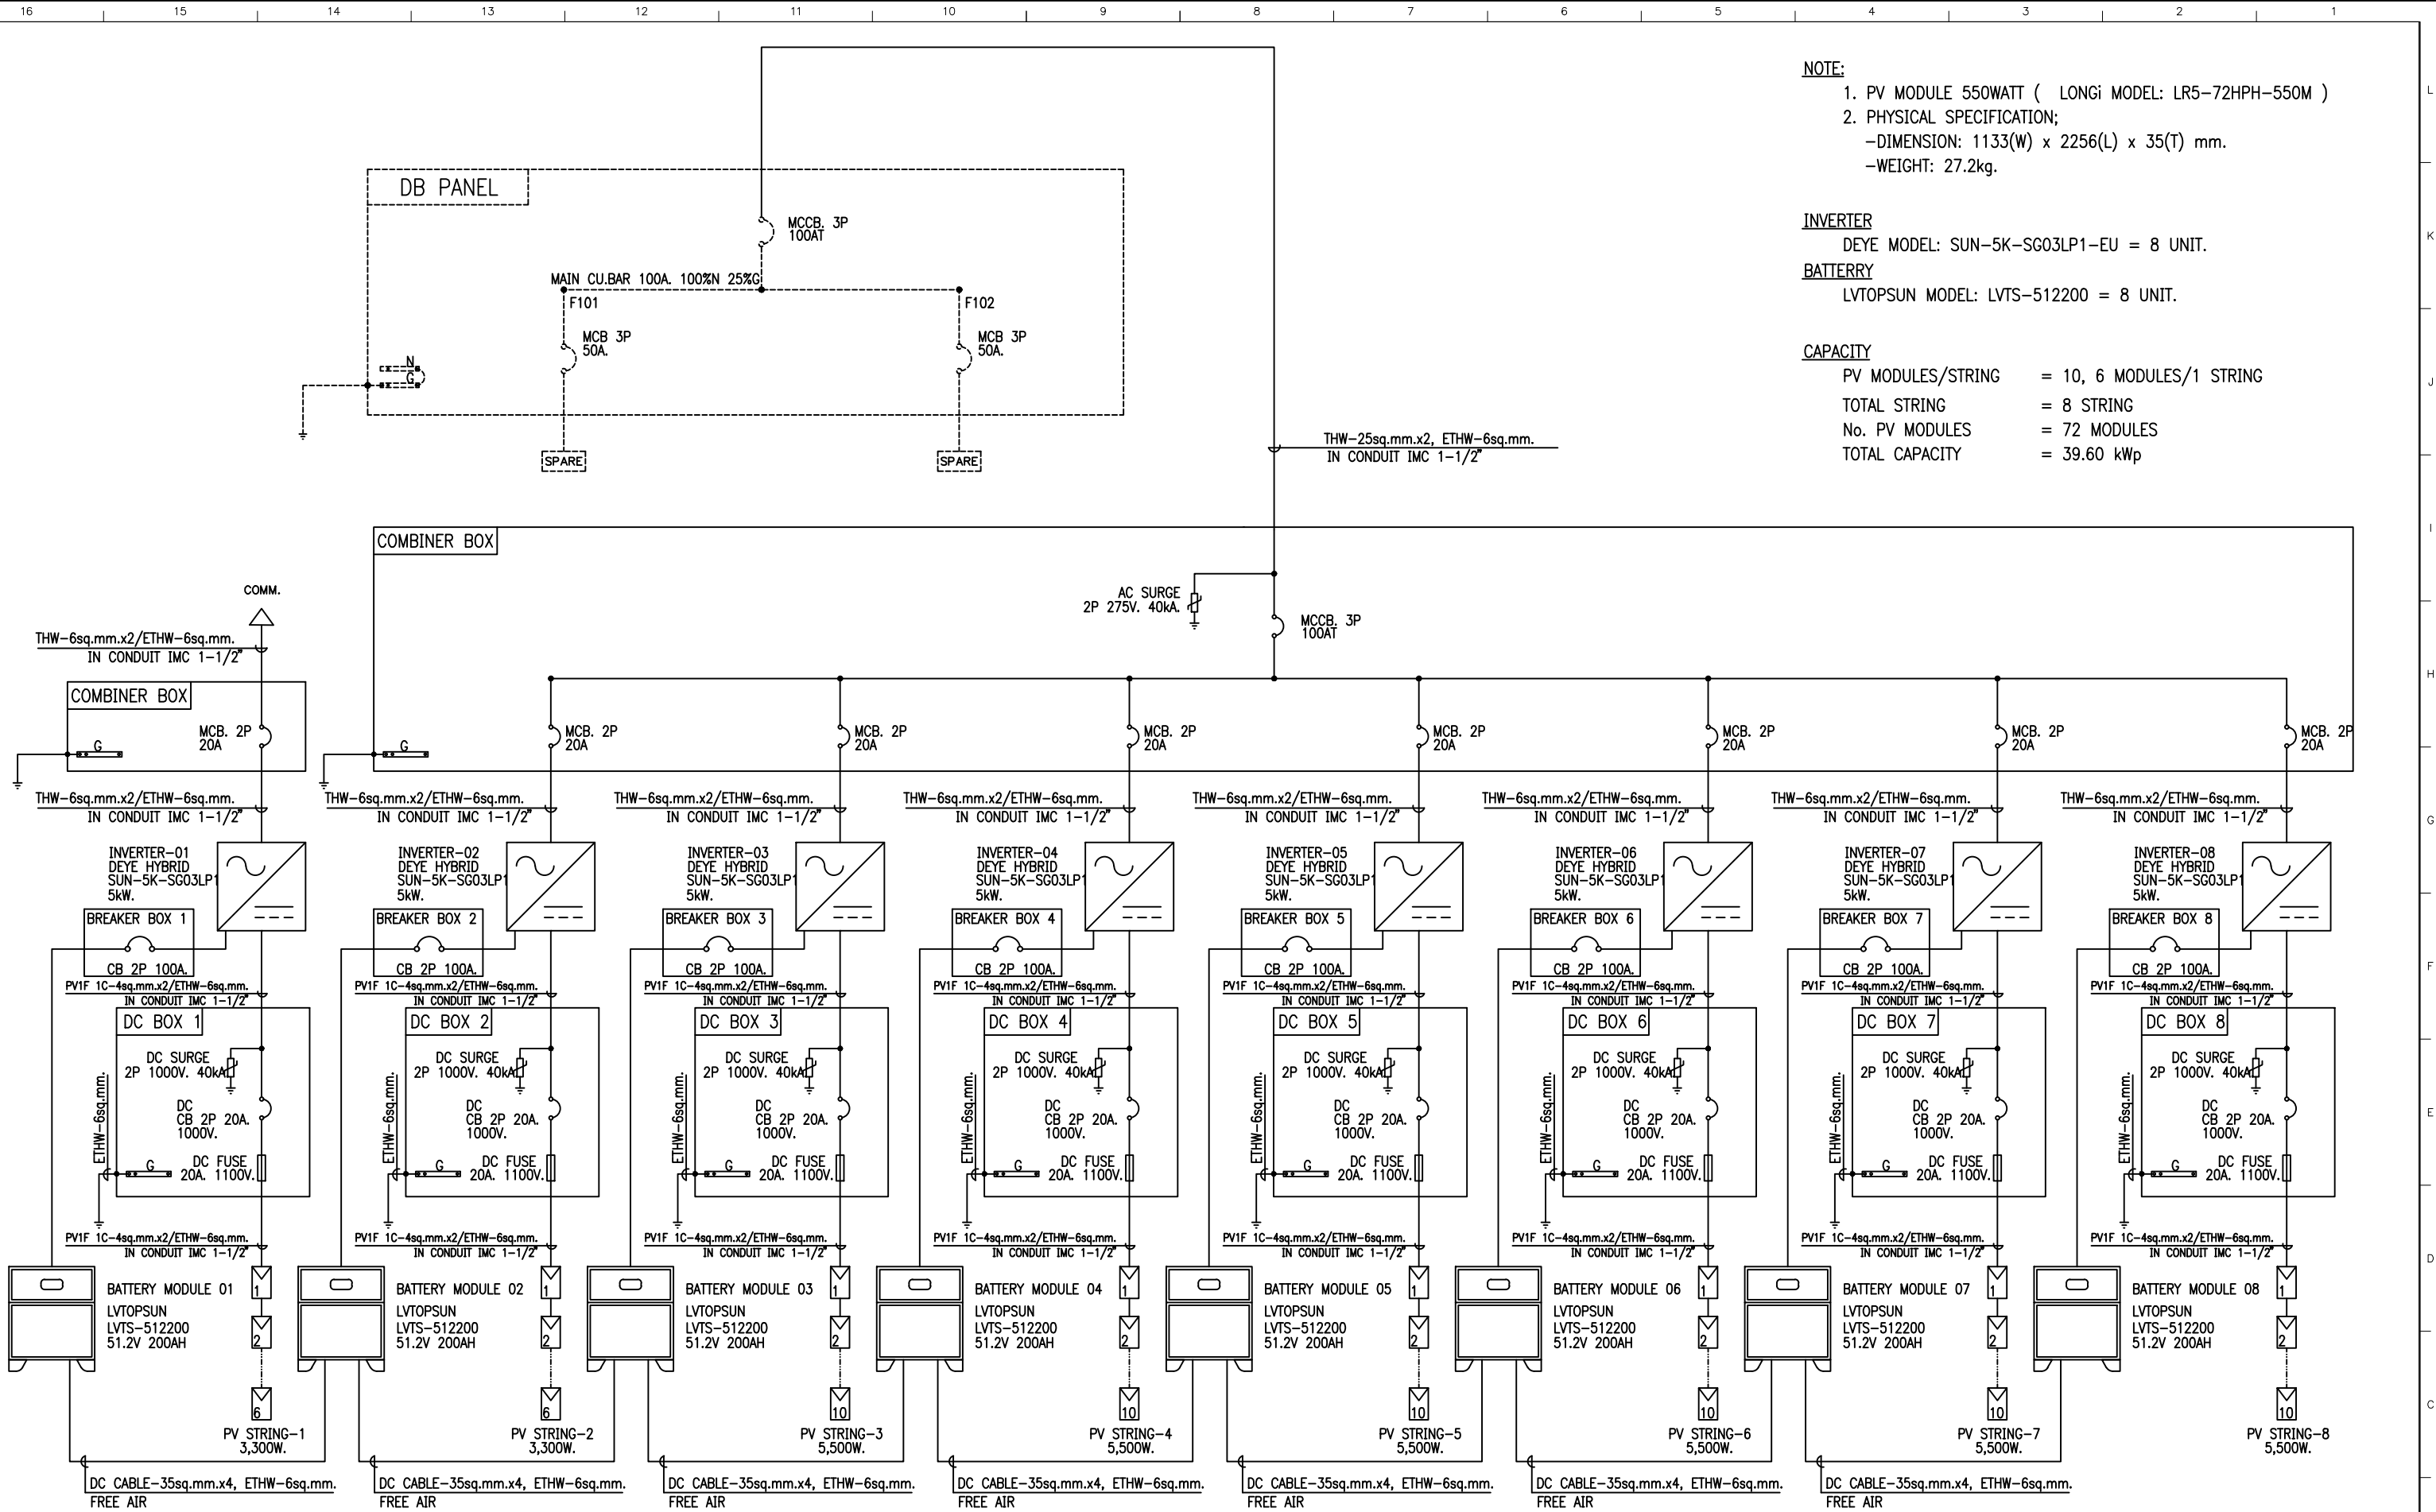




Solar Cell System Single Line Diagram

SCALE

NONE

OFFTAKER :	OWNER : Akhakiri	CONTRACTOR :  SOLAR ESS CO., LTD.	PROJECT NAME Akhakiri 39.60 kWp 3Ph 8String	STRUCTURAL ENGINEERS: DRAWN BY: ARCHITECT: CHECKED BY: ELECTRICAL ENGINEERS:  APPROVED BY: MECHANICAL ENGINEER:	NO. DESCRIPTION DATE ISSUES AND REVISIONS	DRAWING TITLE: DRAWING NO.: DATE : SCALE : SHEET NO. : TOTAL NO. :
						REV. 0