


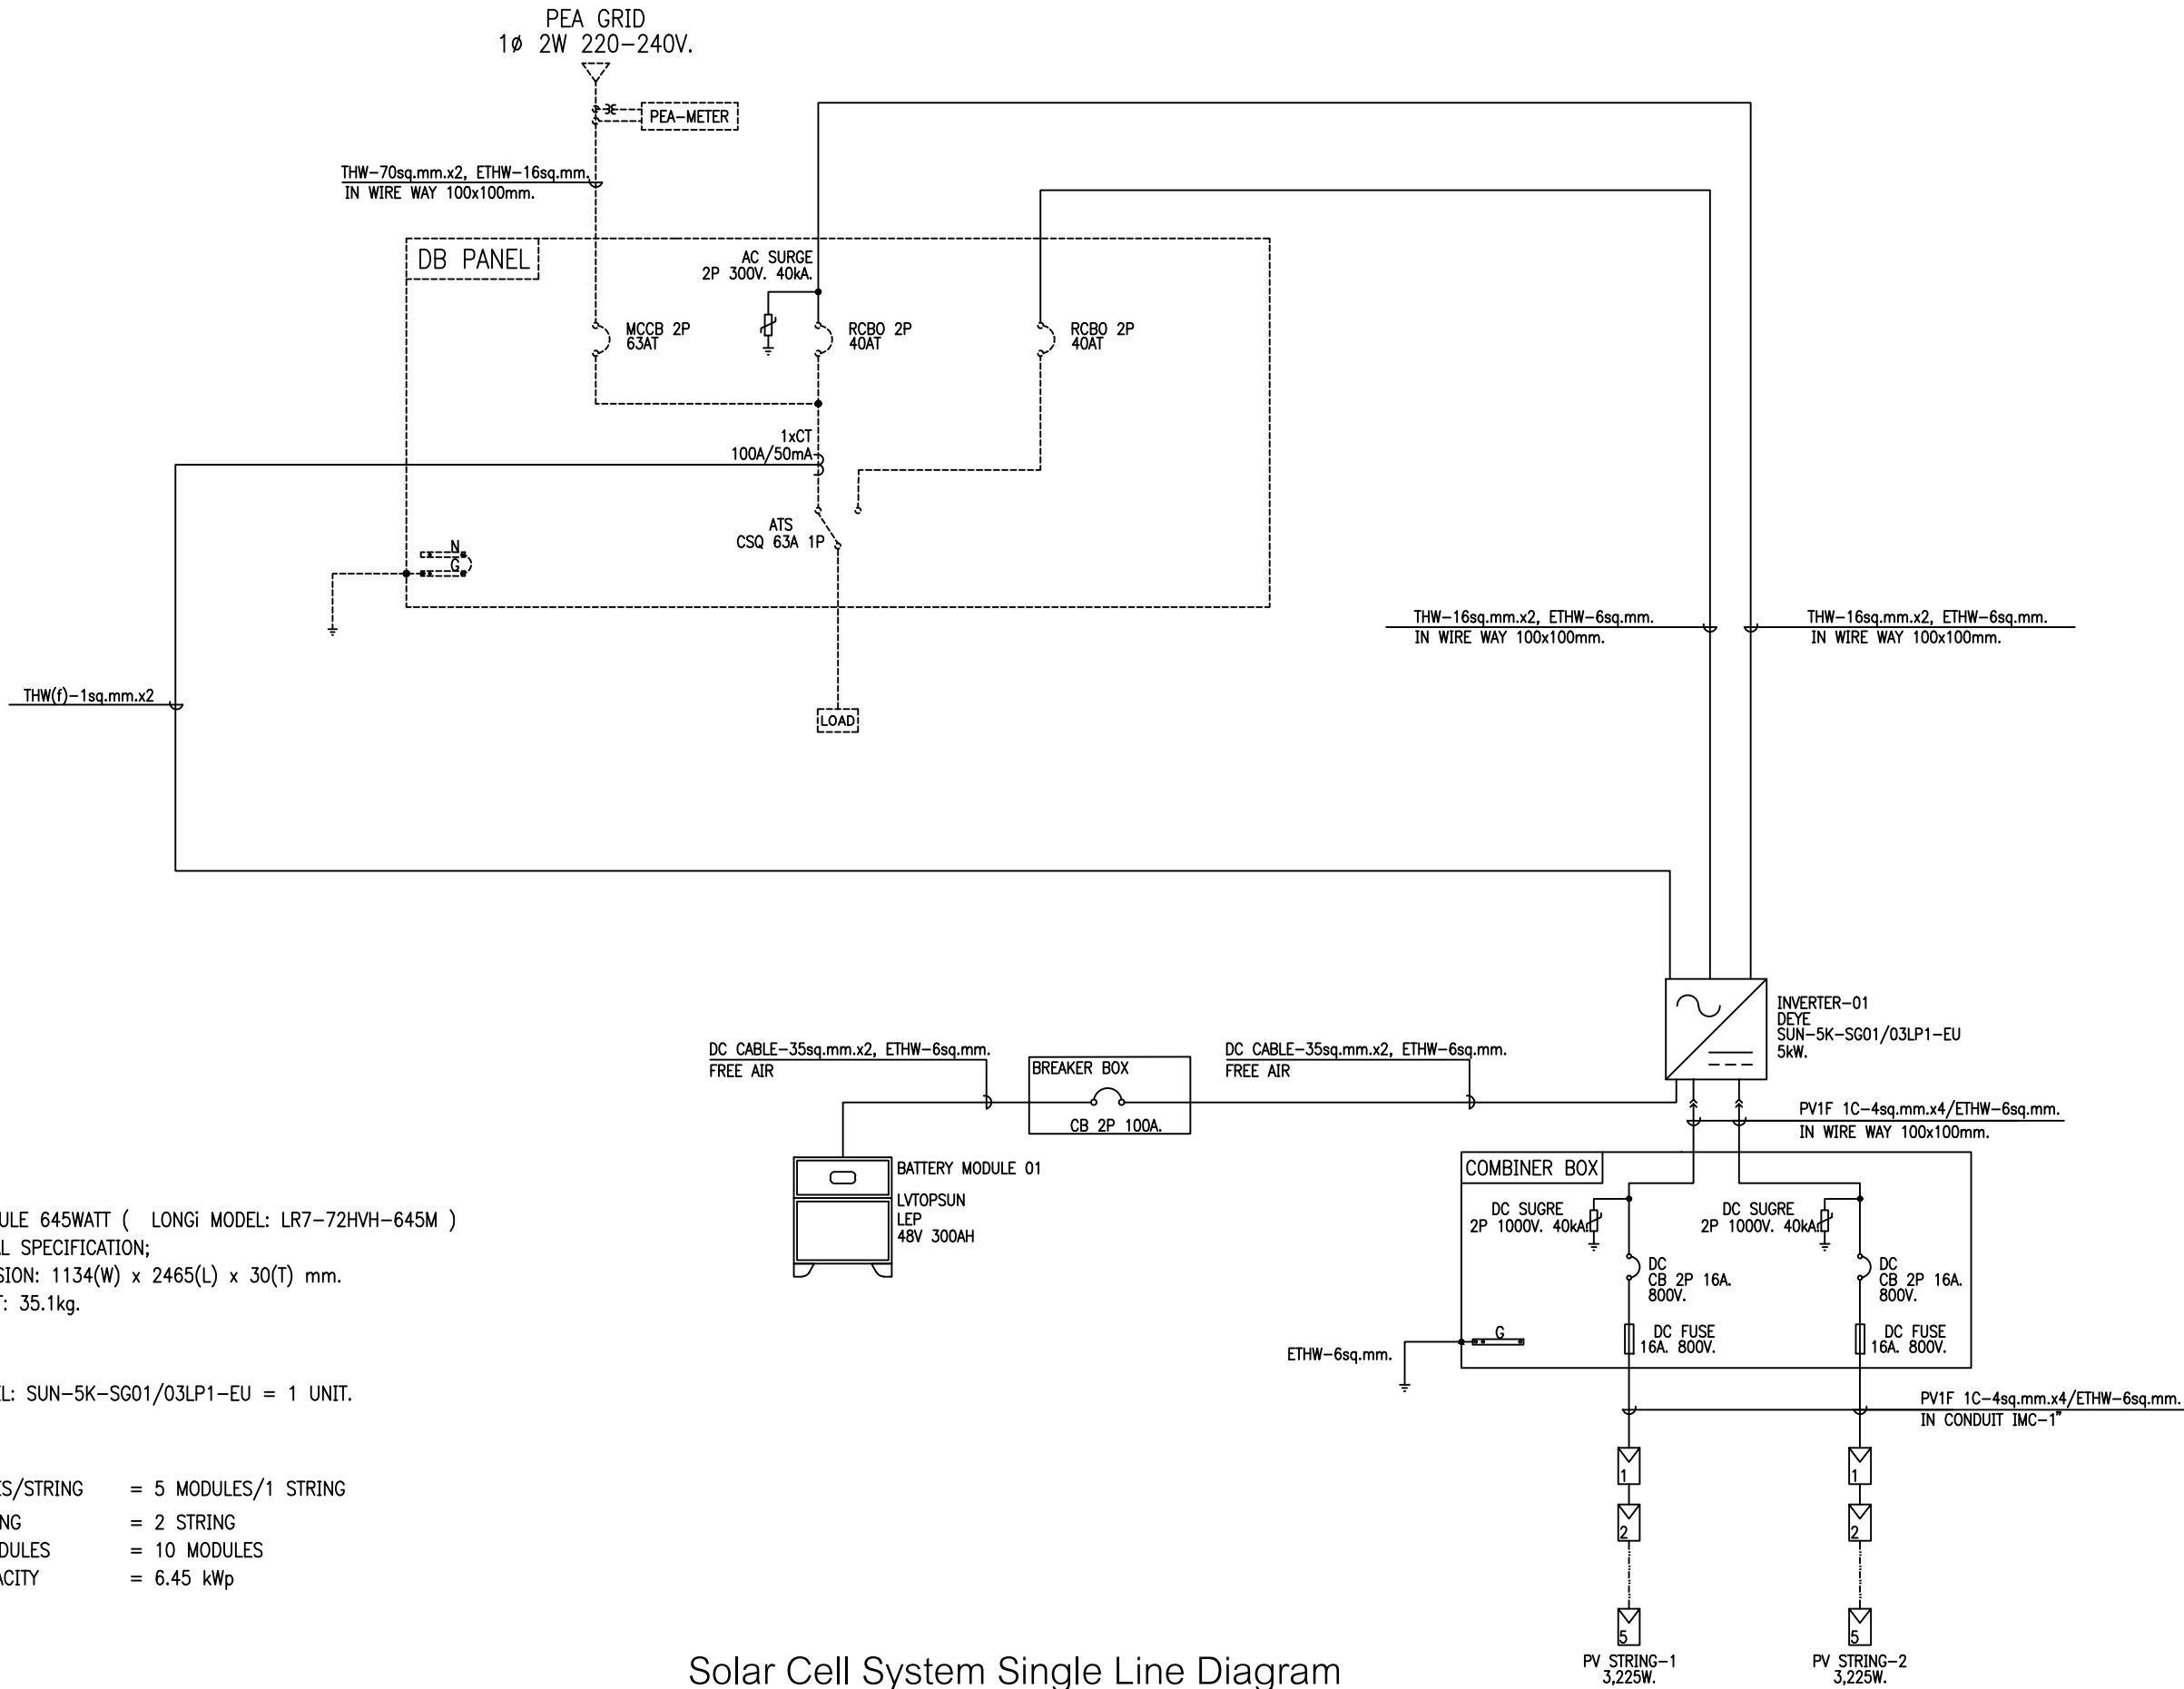

NOTE:

1. PV MODULE 645WATT (LONGi MODEL: LR7-72HVH-645M)
2. PHYSICAL SPECIFICATION;
-DIMENSION: 1134(W) x 2465(L) x 30(T) mm.
-WEIGHT: 35.1kg.

INVERTER

DEYE MODEL: SUN-5K-SG01/03LP1-EU = 1 UNIT.

CAPACITY

PV MODULES/STRING = 5 MODULES/1 STRING
TOTAL STRING = 2 STRING
No. PV MODULES = 10 MODULES
TOTAL CAPACITY = 6.45 kWp

Solar Cell System Single Line Diagram

SCALE NONE

AS-BUILT DRAWING

OFFTAKER :

OWNER :

Saowanee House

CONTRACTOR :



SOLAR ESS CO., LTD.

PROJECT NAME

Saowanee House 6.45kWp 1Ph 2String

STRUCTURAL ENGINEER:

DRAWN BY:

ARCHITECT:

CHECKED BY:

ELECTRICAL ENGINEER:

APPROVED BY:

MECHANICAL ENGINEER:

NO.

DESCRIPTION

DRAWING TITLE:

Solar Cell System Single Line Diagram

DRAWING NO.:

001

REV.

0

DATE :

SCALE :

NTS

SHEET NO. :

1

TOTAL NO. :

1