


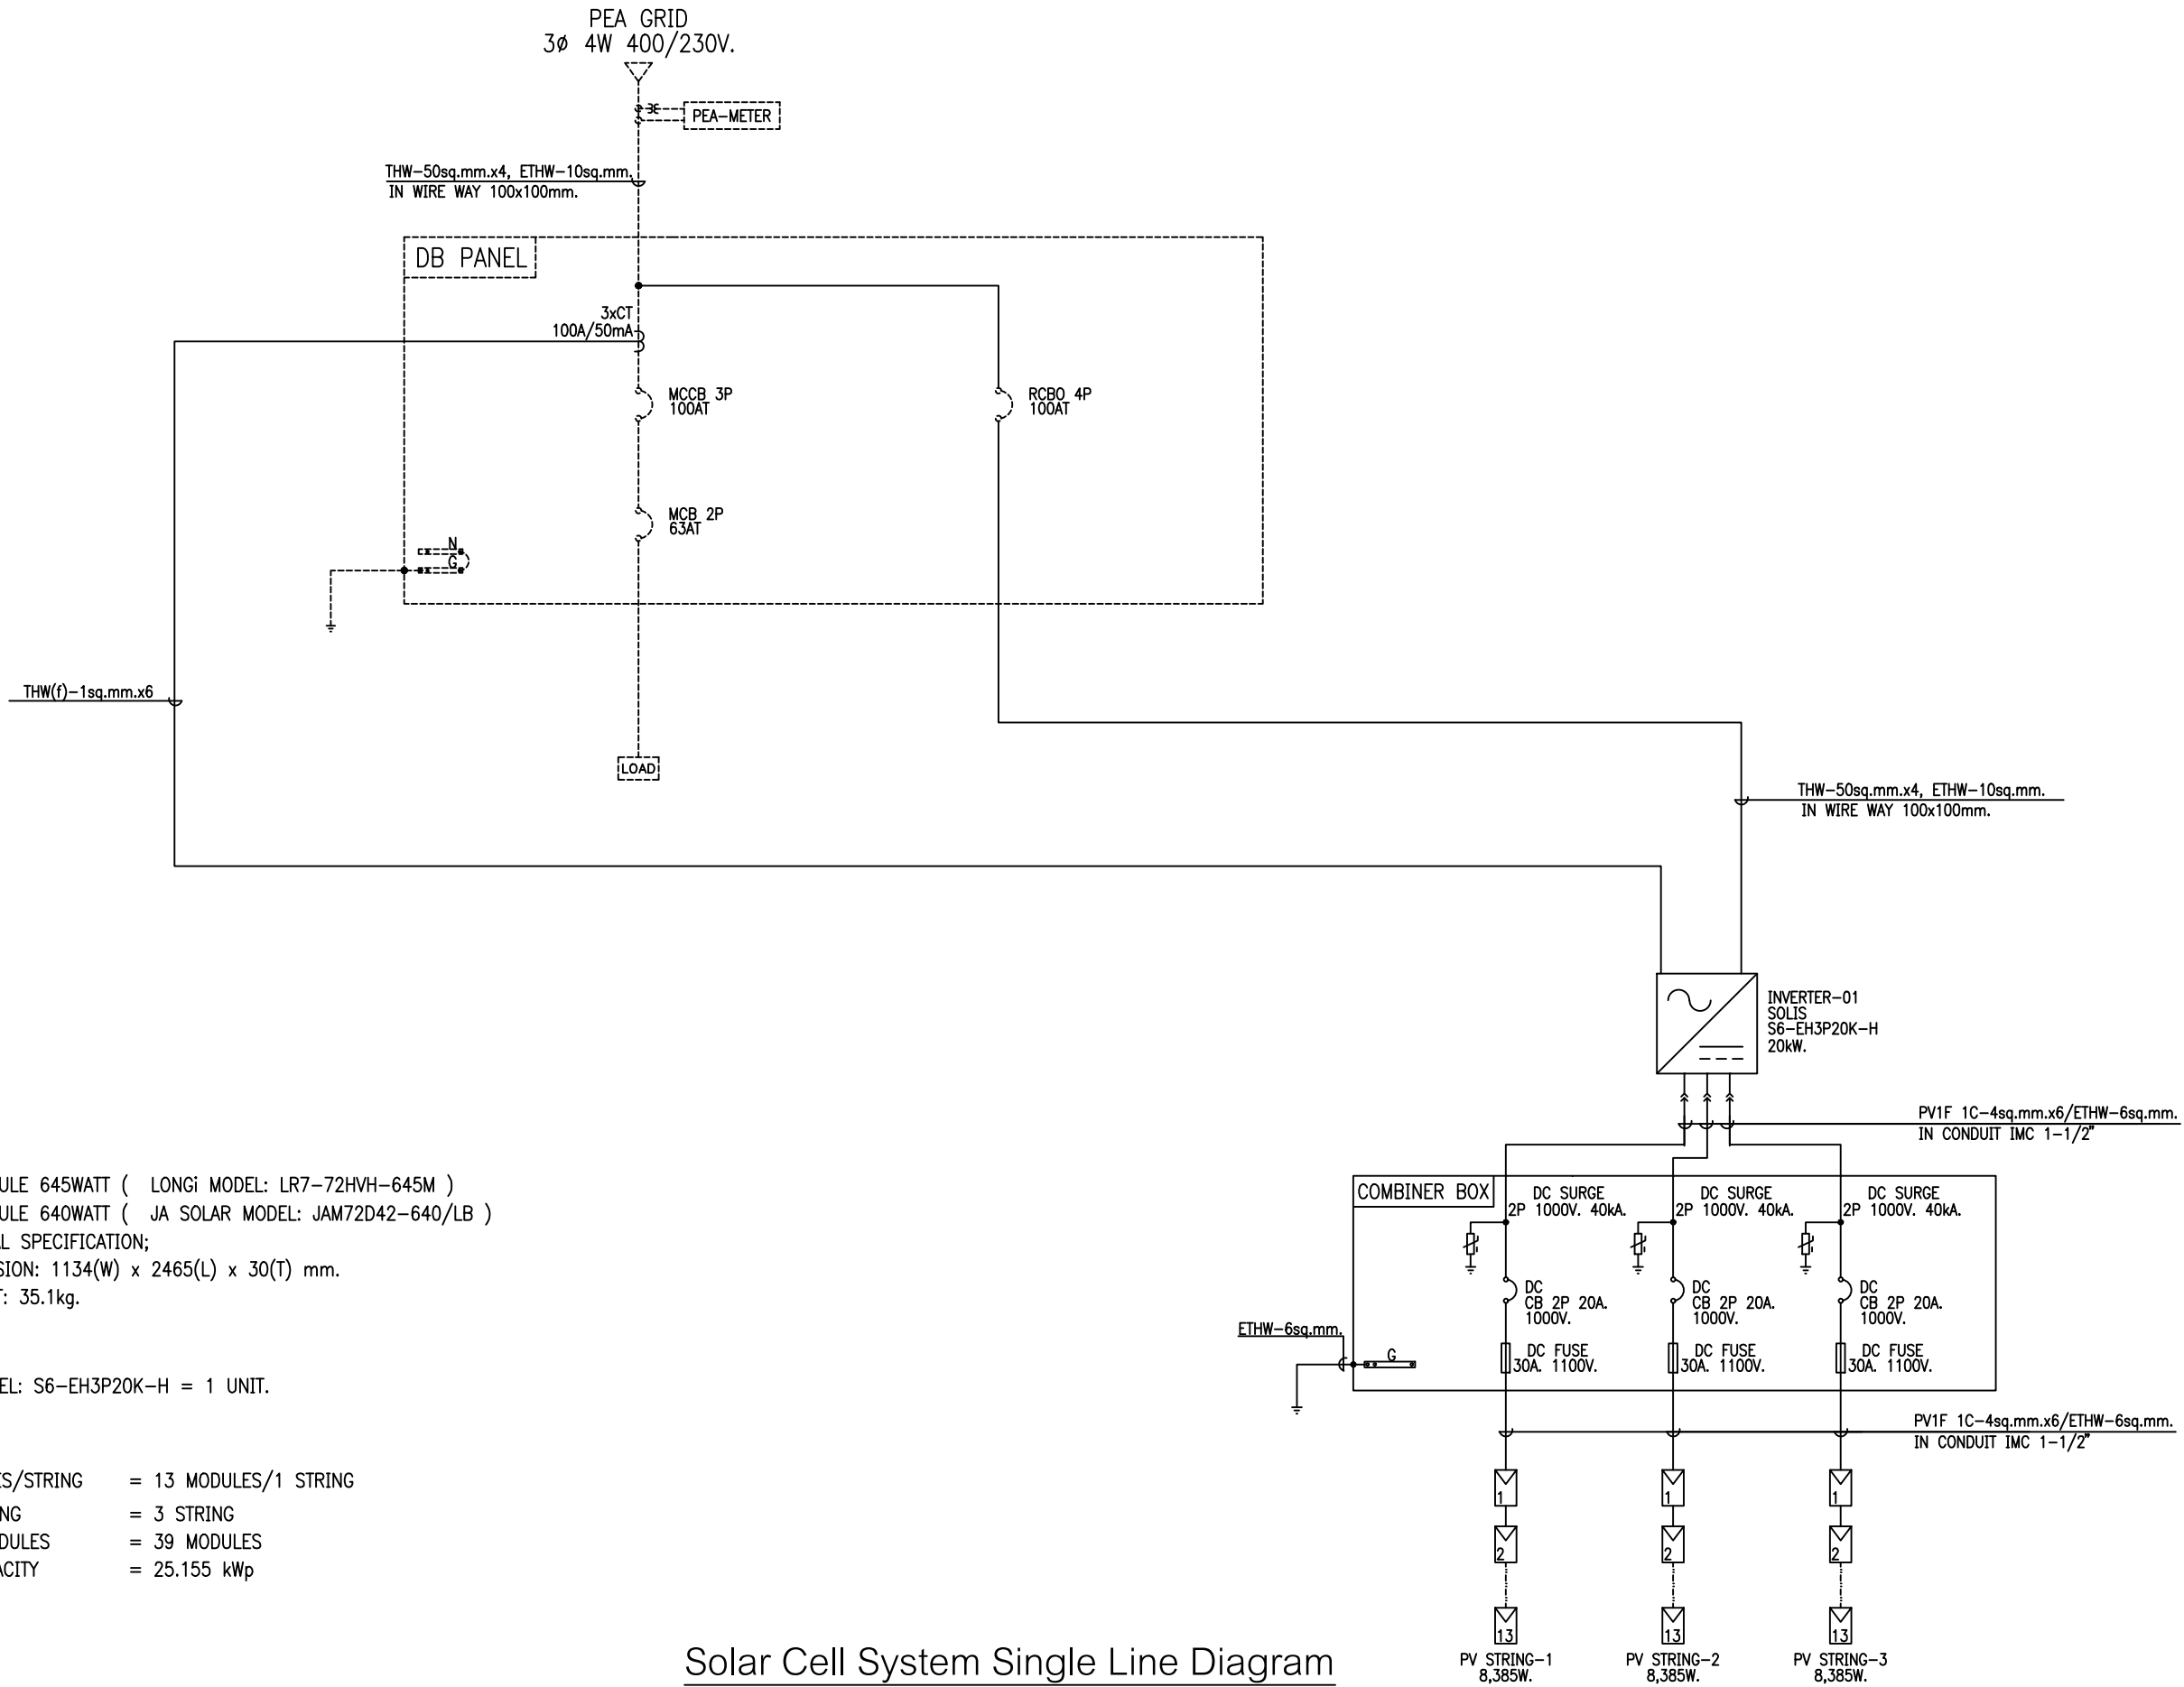

- NOTE:**
- 1. PV MODULE 645WATT (LONGi MODEL: LR7-72HVH-645M)
 - 2. PV MODULE 640WATT (JA SOLAR MODEL: JAM72D42-640/LB)
 - 3. PHYSICAL SPECIFICATION;
-DIMENSION: 1134(W) x 2465(L) x 30(T) mm.
-WEIGHT: 35.1kg.

INVERTER
SOLIS MODEL: S6-EH3P20K-H = 1 UNIT.

CAPACITY	
PV MODULES/STRING	= 13 MODULES/1 STRING
TOTAL STRING	= 3 STRING
No. PV MODULES	= 39 MODULES
TOTAL CAPACITY	= 25.155 kWp

Solar Cell System Single Line Diagram
SCALE NONE

AS-BUILT DRAWING

OFFTAKER :		OWNER :	CONTRACTOR :	PROJECT NAME	STRUCTURAL ENGINEER:	DRAWN BY:	DRAWING TITLE:	
		Kuang Paya Nursing Home		Kuang Paya Nursing Home 25.155kWp 3Ph 3String	ARCHITECT:	CHECKED BY:	Solar Cell System Single Line Diagram	
					ELECTRICAL ENGINEER: 	APPROVED BY: 	DRAWING NO.: 001	
					MECHANICAL ENGINEER:		REV. 0	
					ISSUES AND REVISIONS		DATE :	
							SCALE : NTS	
							SHEET NO. : 1	
							TOTAL NO. : 1	