

NOTE:

1. PV MODULE 550WATT (LONGi MODEL: LR5-72HPH-550M)
2. PHYSICAL SPECIFICATION;
-DIMENSION: 1133(W) x 2256(L) x 35(T) mm.
-WEIGHT: 27.2kg.

INVERTER


DEYE MODEL: SUN-5K-SG03LP1-EU = 1 UNIT.

BATTERY

LVTOPSUN MODEL: LVTS-512200 = 2 UNIT.

CAPACITY

PV MODULES/STRING = 5, 4 MODULES/1 STRING
TOTAL STRING = 2 STRING
No. PV MODULES = 9 MODULES
TOTAL CAPACITY = 4.95 kWp

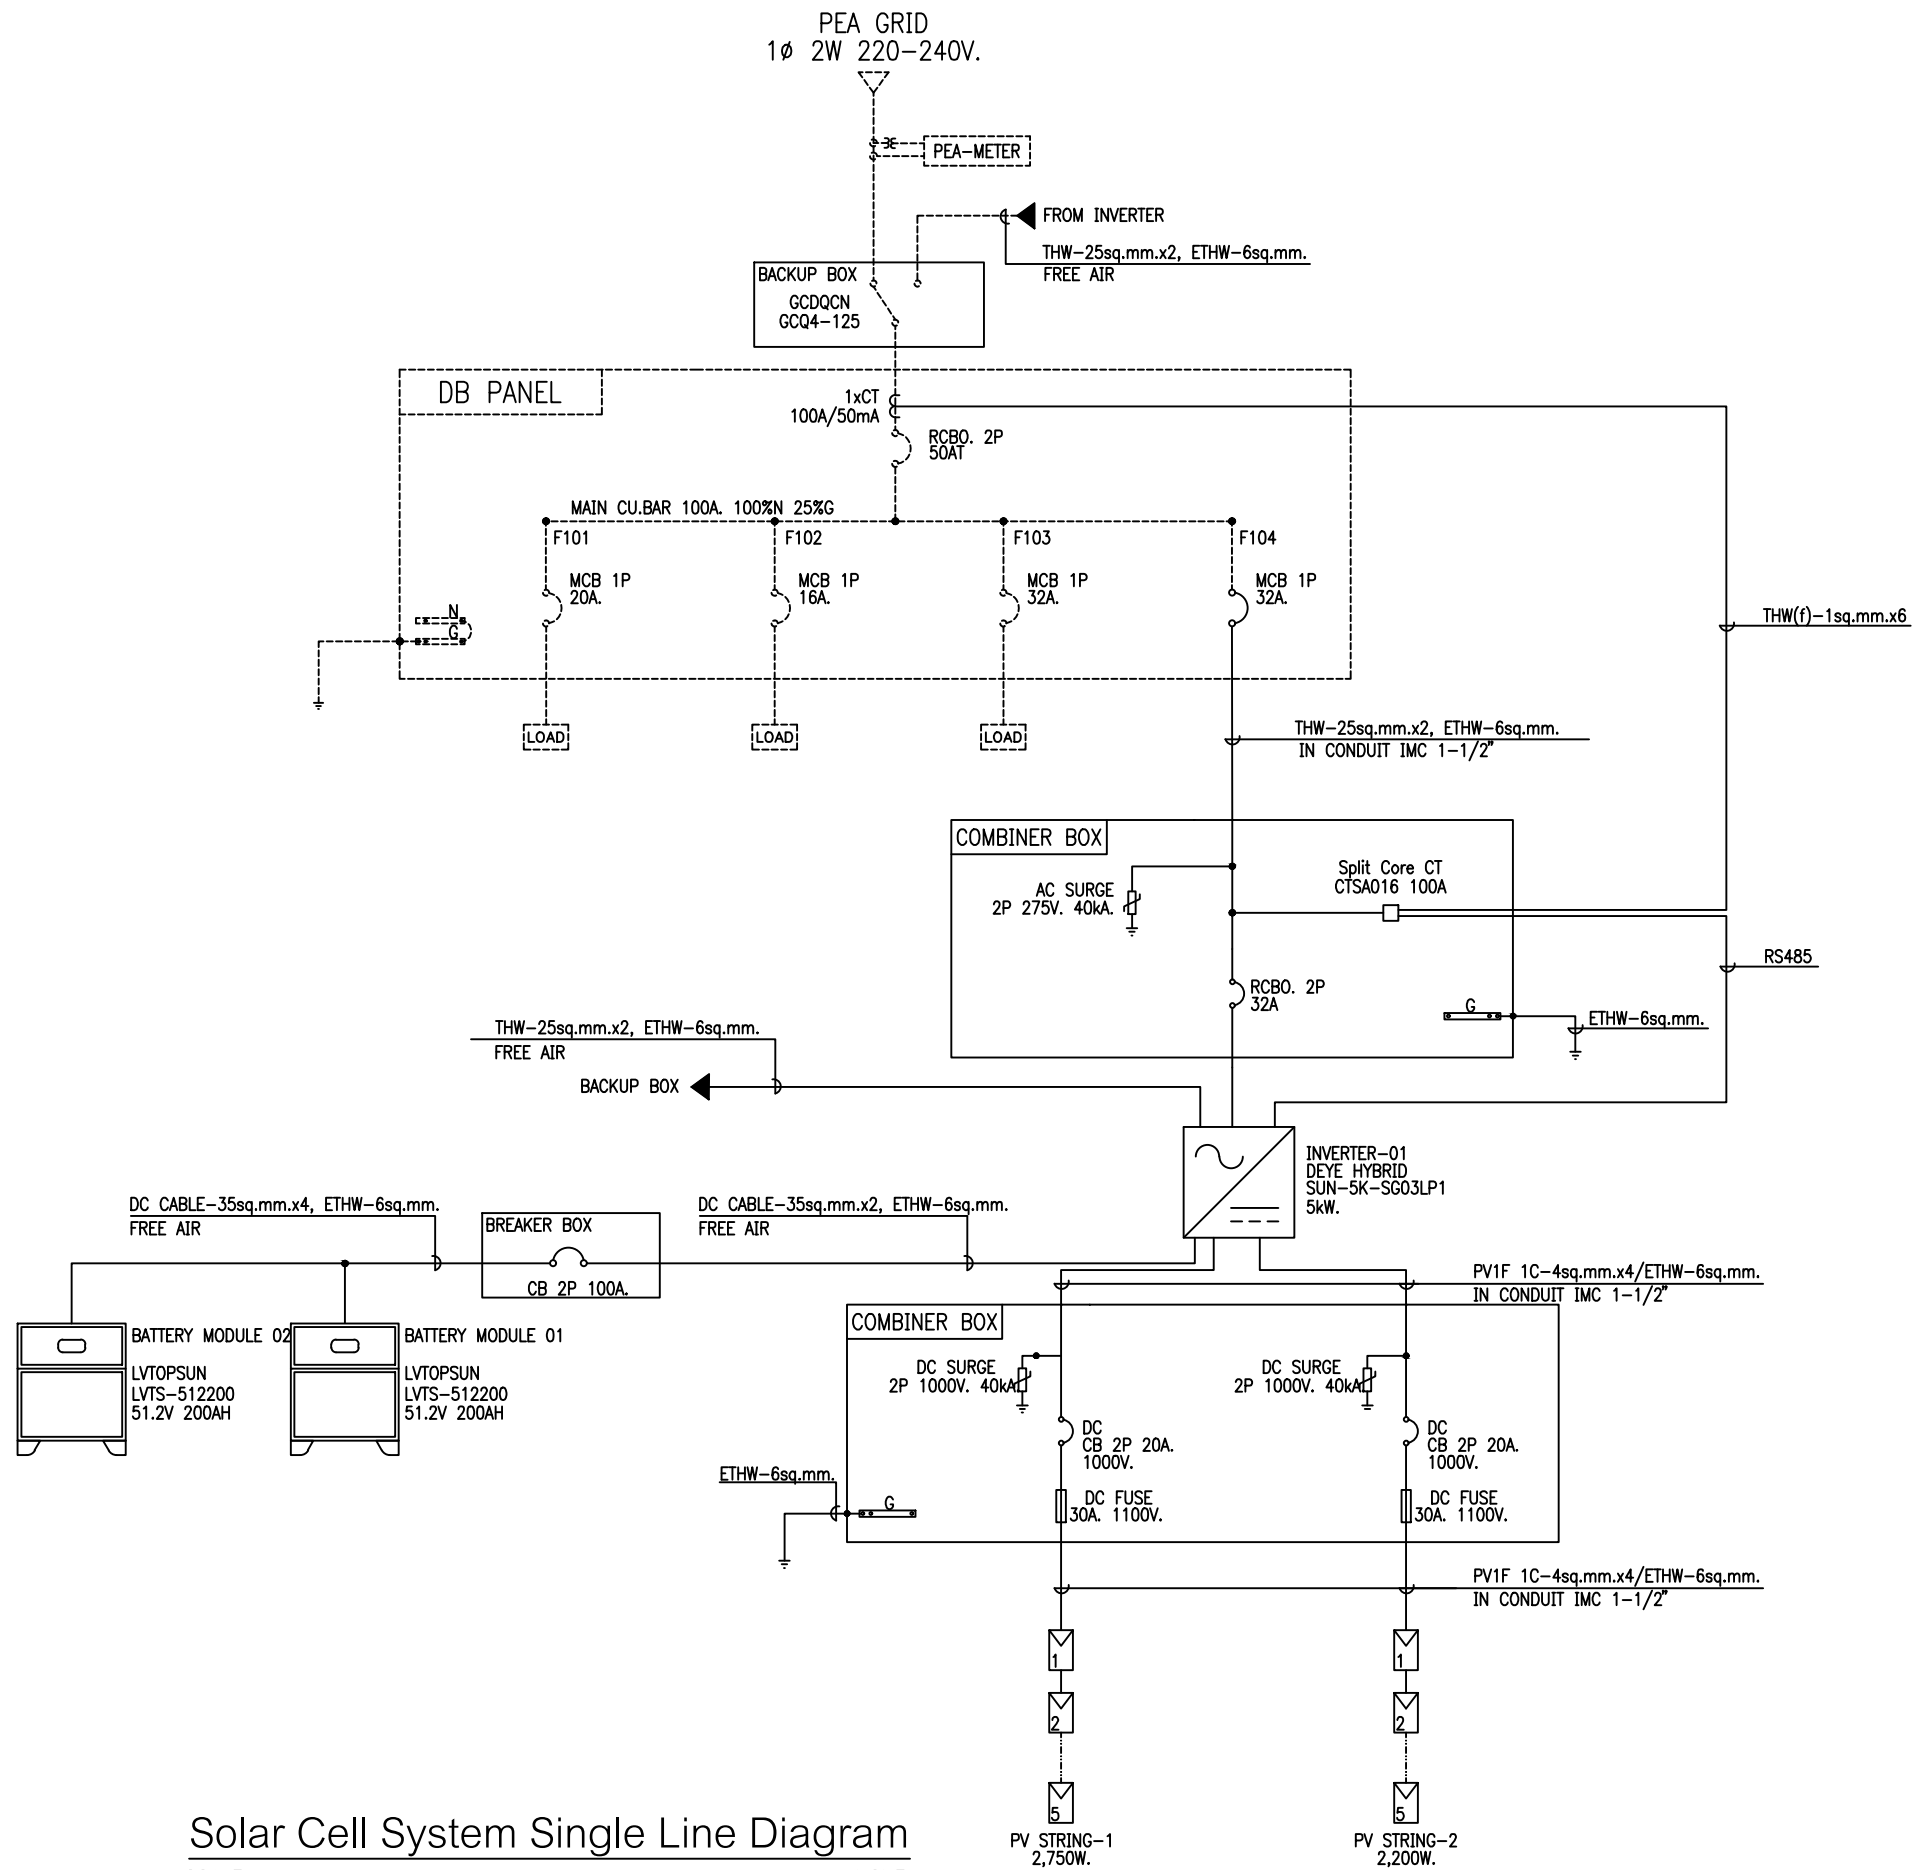

Solar Cell System Single Line Diagram

SCALE

NONE

AS-BUILT DRAWING

OFFTAKER :

OWNER :

คุณดวงดาว ตามี

CONTRACTOR :



SOLAR ESS CO., LTD.

PROJECT NAME

บ้านคุณดวงดาว 4.95kW 1Ph 2String

STRUCTURAL ENGINEER:

DRAWN BY:

ARCHITECT:

CHECKED BY:

ELECTRICAL ENGINEER:

APPROVED BY:

MECHANICAL ENGINEER:

AS-BUILT DRAWING

NO. DESCRIPTION DATE

ISSUES AND REVISIONS

DRAWING TITLE:

Solar Cell System Single Line Diagram

DRAWING NO.:

001

DATE :

SCALE :

NTS

SHEET NO. :

1

TOTAL NO. :

1